

PROJECT
Dunvant RFC

TITLE
Proposed Floor Plans


SCALE	1:100	JOB No.	S 962
DATE	July 05	DRAWN	
CHECKED			

DRAWING No. 962-001 REVISION

NOTES

Figured dimensions must be used only.
Do not scale measurements.
Contractor must check all dimensions on site & certify them as correct.
The copyright of this drawing is to remain the property of W.Griffiths & Glass.

REV.	AMENDMENTS	DATE	BY

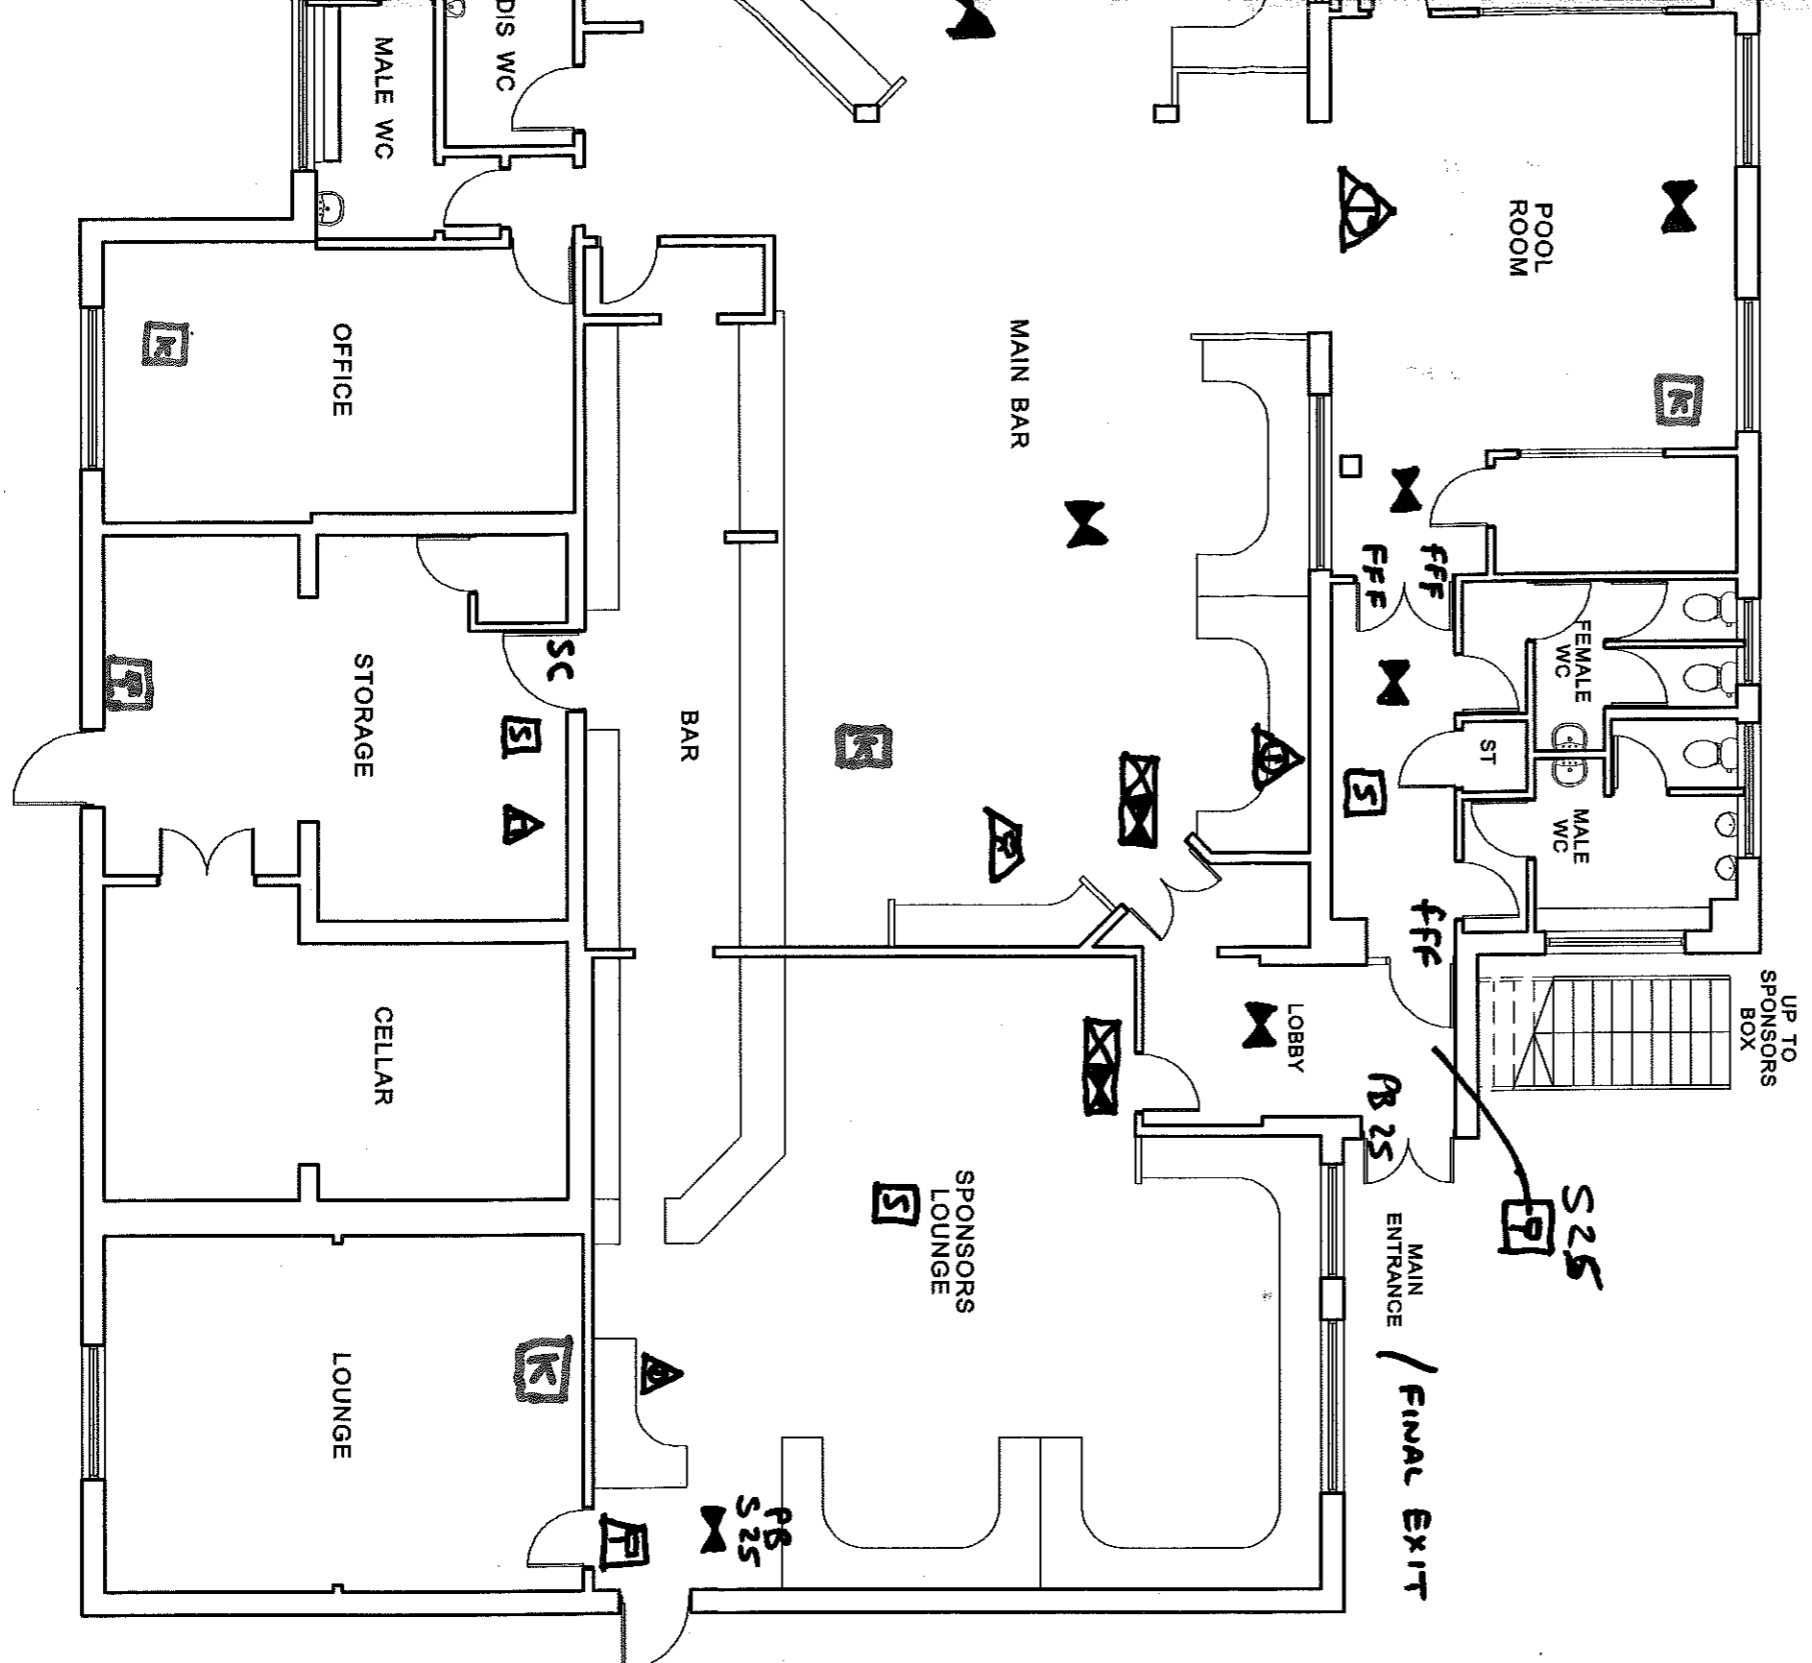

KEY

- [R] HEAT DETECTOR
- S25 - FIRE EXIT NOTICE
- S25 - PUSH BAR TO OPEN Notice
- PB - 'PUSH BAR'
- SC - SELF CLOSING DEVICE
- PP - PUSH PANELS
- [X] - EMERGENCY LIGHT
- [X] - EMERGENCY LIGHTS
- [P] - PUSH BUTTON ALARM
- FFP - DOOR FREE FROM FASTENING
- [R] - AUDIBLE WARNING ALARM
- FINAL EXIT.
- [A] - WATER EXTINGUISHER.
- [A] - DRY POWDER EXTINGUISHER.
- [C] - FIRE BLANKET
- [S] - SMOKE DETECTOR
- [M] - EMERGENCY LIGHTS.